


PLANS FOR CONSTRUCTION

GOLDEN STATE BOULEVARD PROJECT
FROM MOUNTAIN VIEW AVE TO TULARE COUNTY
PROJECT LENGTH 14.1 MI.

INDEX OF SHEETS

SHEET	DRAWING	DESCRIPTION
1	T-1	TITLE SHEET
2	G-1	GENERAL NOTES
3 TO 7	X-1 TO X-5	TYPICAL SECTIONS
8 TO 9	K-1 TO K-2	KEY MAP
10 TO 12	PC-1 TO PC-3	PROJECT CONTROL
13 TO 38	L-1 TO L-26	LAYOUT
39 TO 60	CD-1 TO CD-22	CONSTRUCTION DETAILS
61 TO 69	D-1 TO D-9	DRAINAGE PLAN
70	DD-1	DRAINAGE DETAILS
71 TO 83	U-1 TO U-13	UTILITY PLAN
84	CS-1	CONSTRUCTION AREA SIGNS
85 TO 88	SC-1 TO SC-4	STAGE CONSTRUCTION PLANS
89 TO 101	SS-1 TO SS-13	SIGNAGE AND STRIPING PLANS
102 TO 104	E-1 TO E-3	STREET LIGHTING PLANS
105 TO 115	E-4 TO E-14	TRAFFIC SIGNAL PLANS
116	PL-1	PLANTING LEGEND
117 TO 128	PP-1 TO PP-12	PLANTING PLAN
129	LD-1	LANDSCAPE DETAIL
130	IL-1	IRRIGATION LEGEND
131 TO 142	IP-1 TO IP-12	IRRIGATION PLAN
143	ID-1	IRRIGATION DETAILS
144	ID -2	MWEO DATA

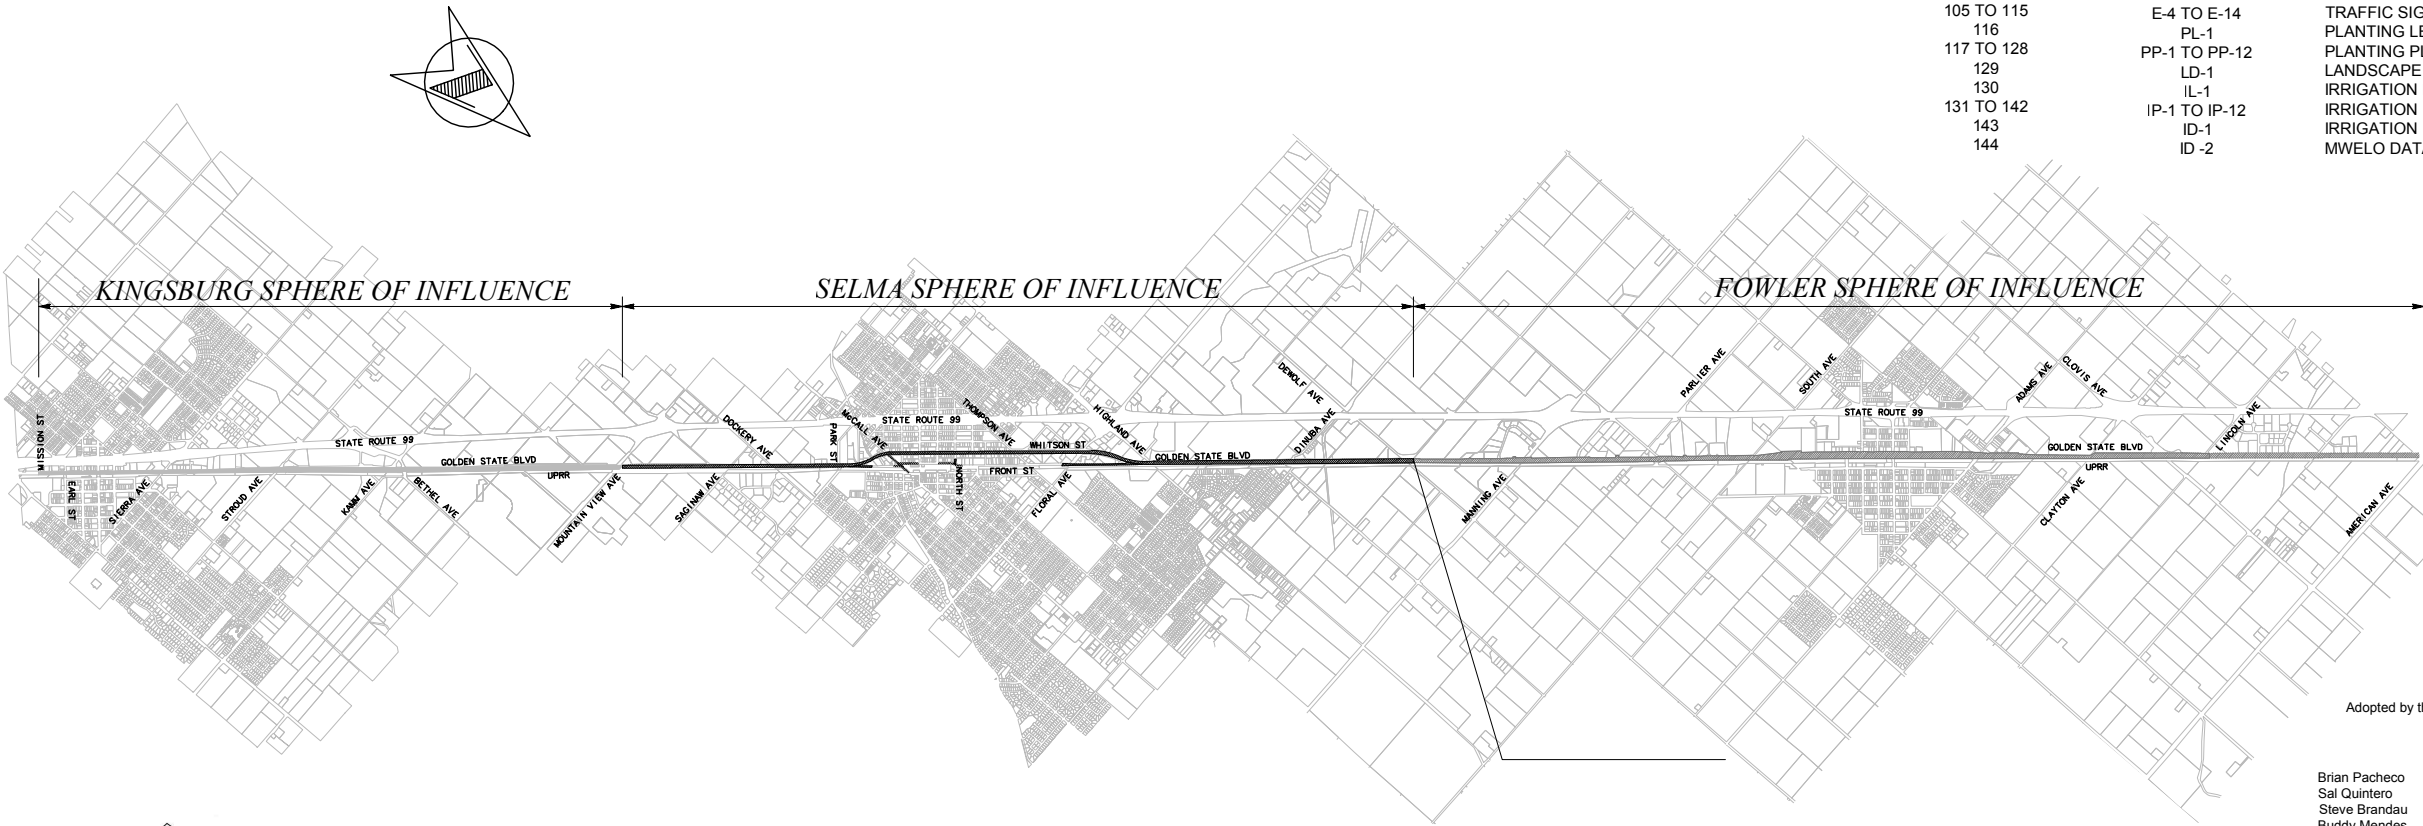

Adopted by the County of Fresno Board of Supervisors

, 20

Brian Pacheco	1st	District
Sal Quintero	3rd	District
Steve Brandau	2nd	District
Buddy Mendes	4th	District
Nathan Magsig	5th	District


Vice Chairman
Chairman

APPROVED


Steven E. White, Director
Department of Public Works, County of Fresno

APPROVED

Shane Ferrell, Director
Department of Public Works, City of Selma

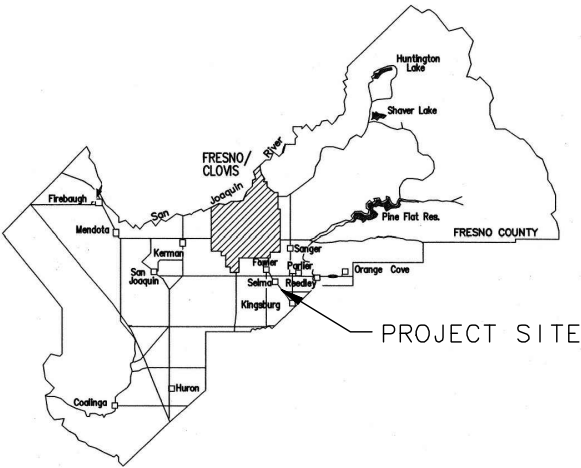

PROJECT SITE

 

DEPARTMENT OF PUBLIC WORKS AND PLANNING

CONTRACTOR'S LICENSING REQUIREMENT					
CLASS A, GENERAL ENGINEERING					
C-12, EARTHWORK AND PAVING					
Drawing No.	Road No.	Bridge No.	Fiscal Yr.	Sheet No.	Total
###	XXXXXX	XXXXX	XXXX	1	144
Contract No. ###					
RECORD DRAWING					
NAME					
ADDRESS					
CITY					
STATE					
ZIP					
PHONE					
DATE AWARDED					
DATE STARTED					
DATE COMPLETED					
RESIDENT ENGINEER					
NAME					
SIGNATURE					
NAME					
SIGNATURE					

90% SUBMITTAL